

RICHMOND TOWN HALL  
RICHMOND, VERMONT


BLACK  
RIVER  
DESIGN  
73 MAIN STREET  
MONTPELIER, VERMONT 05602

REVISIONS	

BASEMENT DEMO PLAN	
SCALE	As indicated
DATE	9/29/2022
DRAWN BY	ADM
CHECKED BY	Checker

AD-01

DEMOLITION NOTES	
KEYNOTE#	KEYNOTE DESCR.
D01	DEMO WOOD FRAMED WALL
D02	DEMO DOOR AND FRAME
D03	DEMO DOUBLE HUNG WINDOW
D04	DEMO ACCESS DOOR AT MASONRY OPENING
D05	DEMO WOOD INFILLING PANEL AT MASONRY OPENING
D06	DEMO PLUMBING FIXTURE(S)

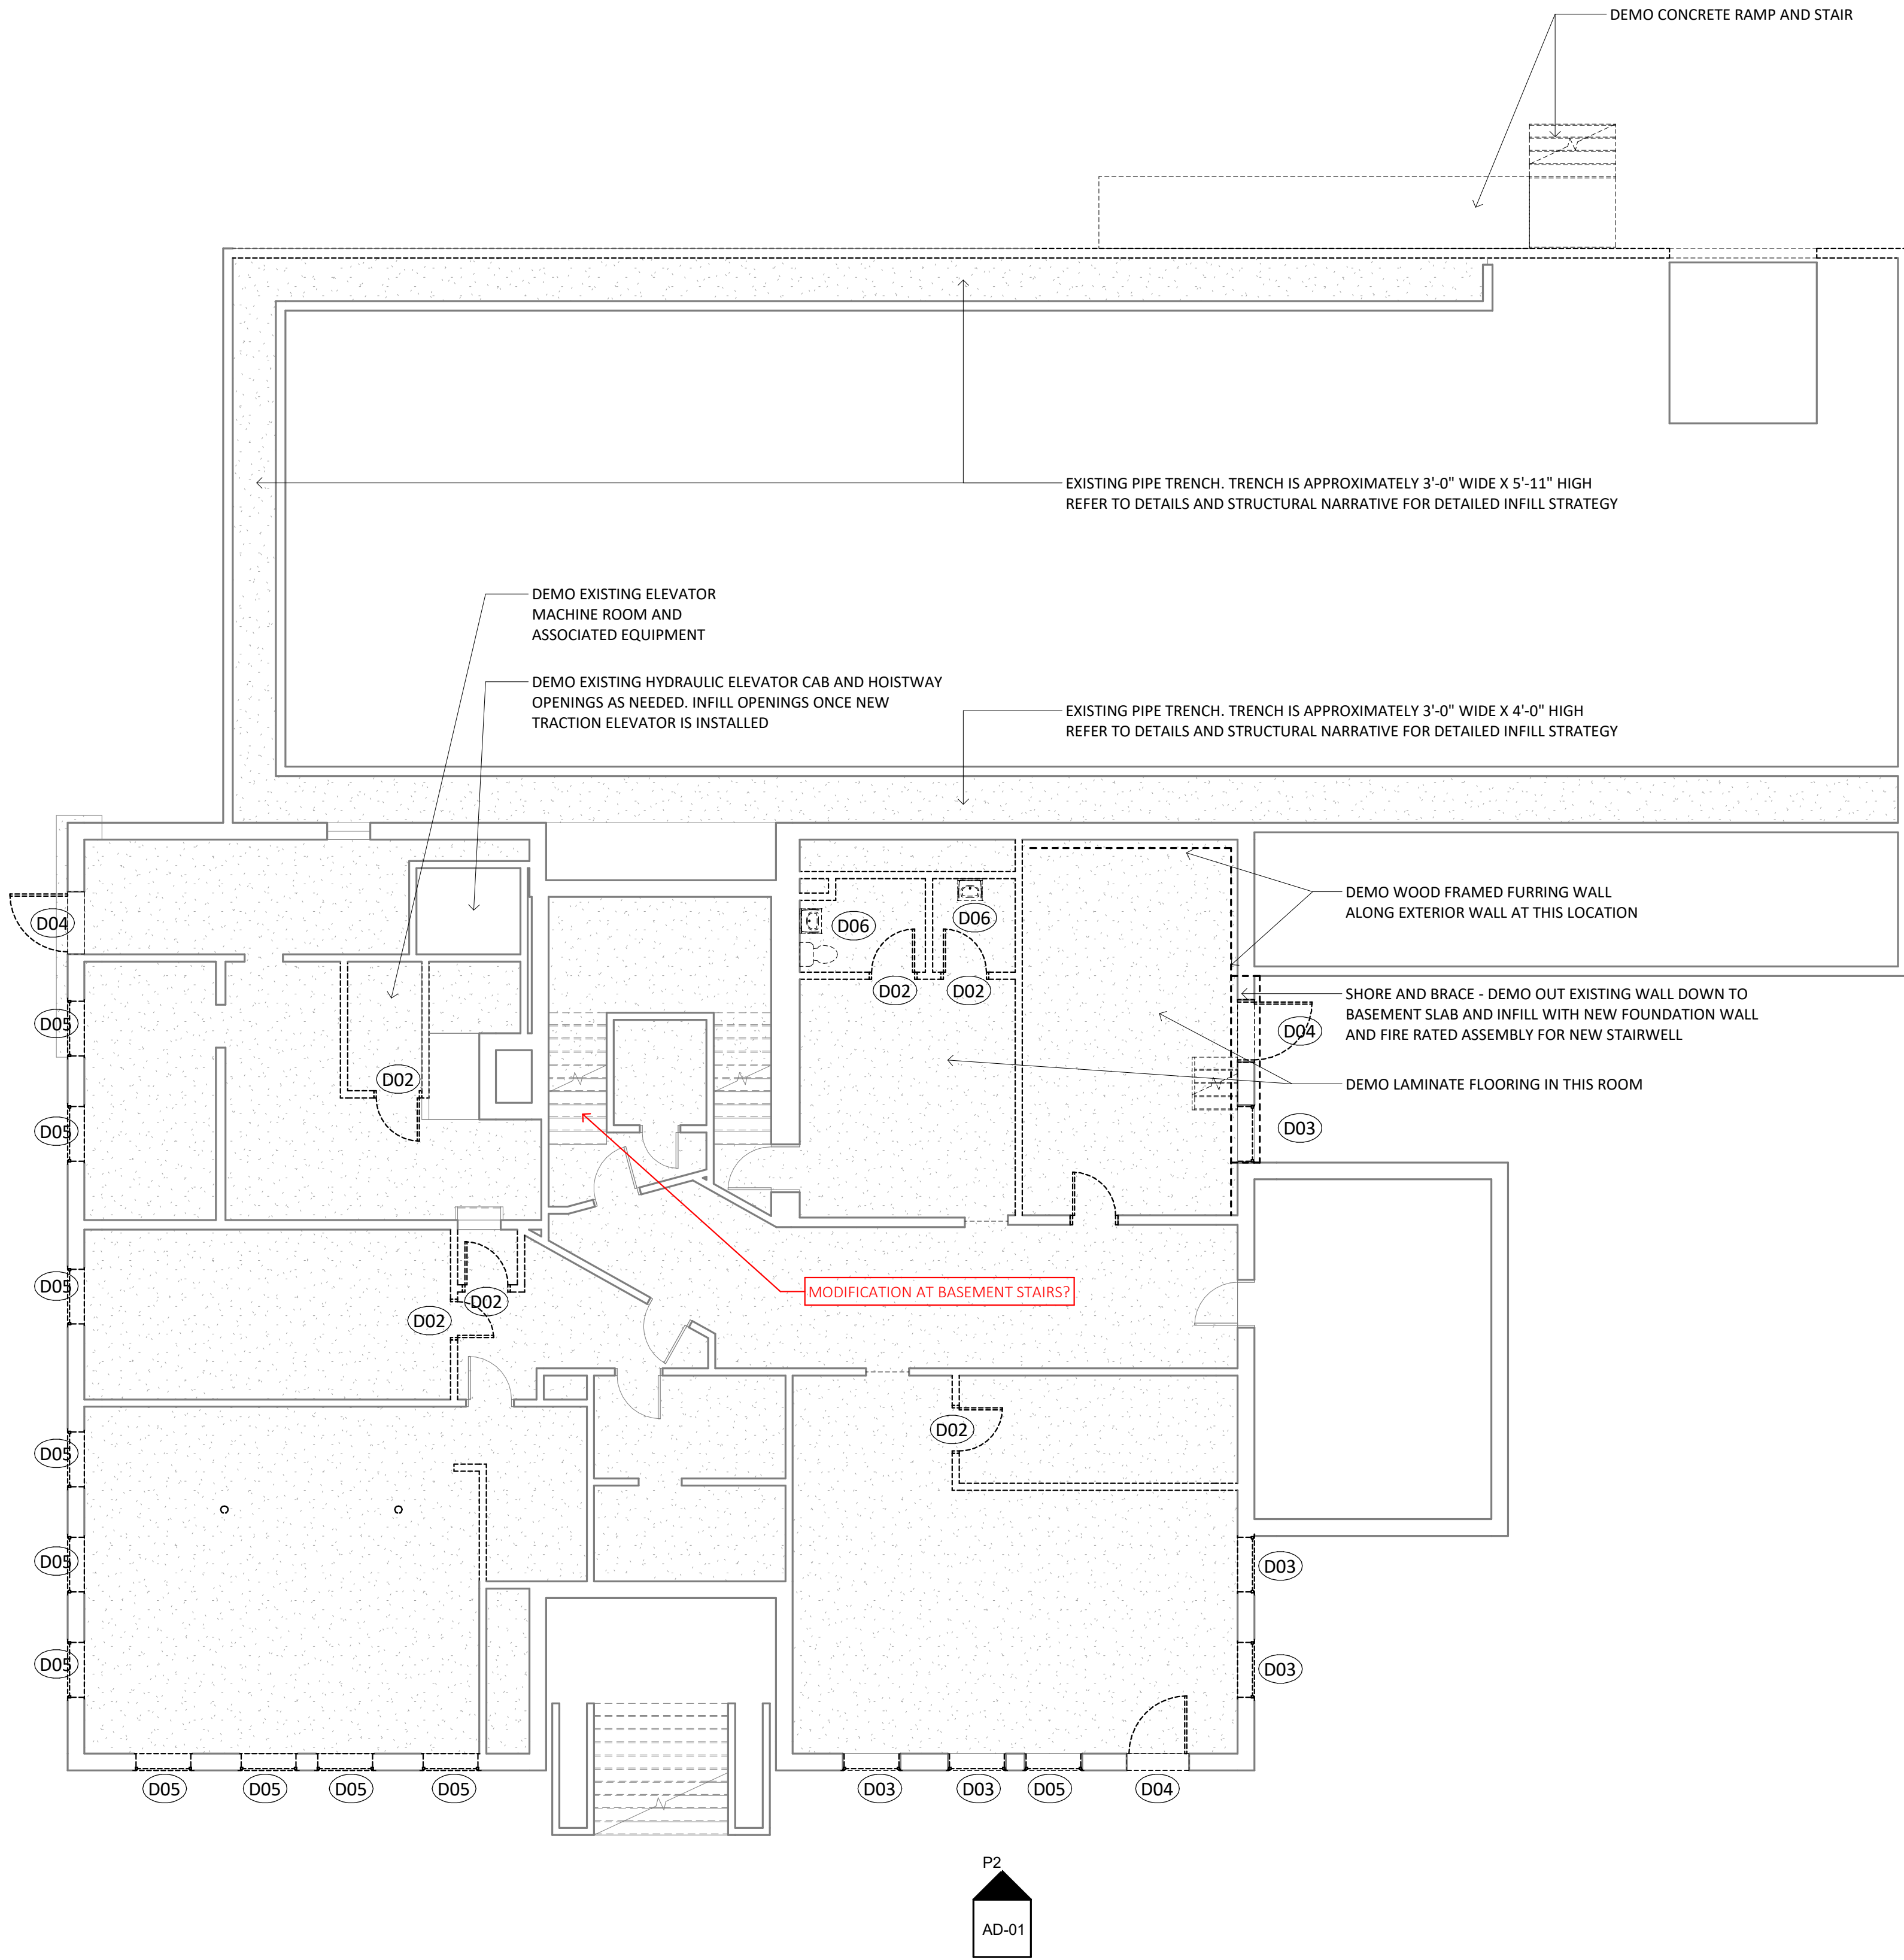

DEMO EXISTING 1' X 2' WALL  
VENTS. INSULATE STUD CAVITY,  
INSTALL NEW SHEATHING, AND  
TOOTH IN NEW BRICK TO MATCH.  
ASSUME A TOTAL OF (24) FOR  
ENTIRE BUILDING

2 P2  
SCALE: 1 1/2" = 1'-0"

1 DEMOLITION PLAN - BASEMENT  
SCALE: 1/8" = 1'-0"

FEASIBILITY DRAWINGS - NOT FOR CONSTRUCTION